


NOTE: PORTABLE FIRE EXTINGUISHERS SHALL BE INSTALLED AS REQUIRED BY SECTION 906.1, OBC.

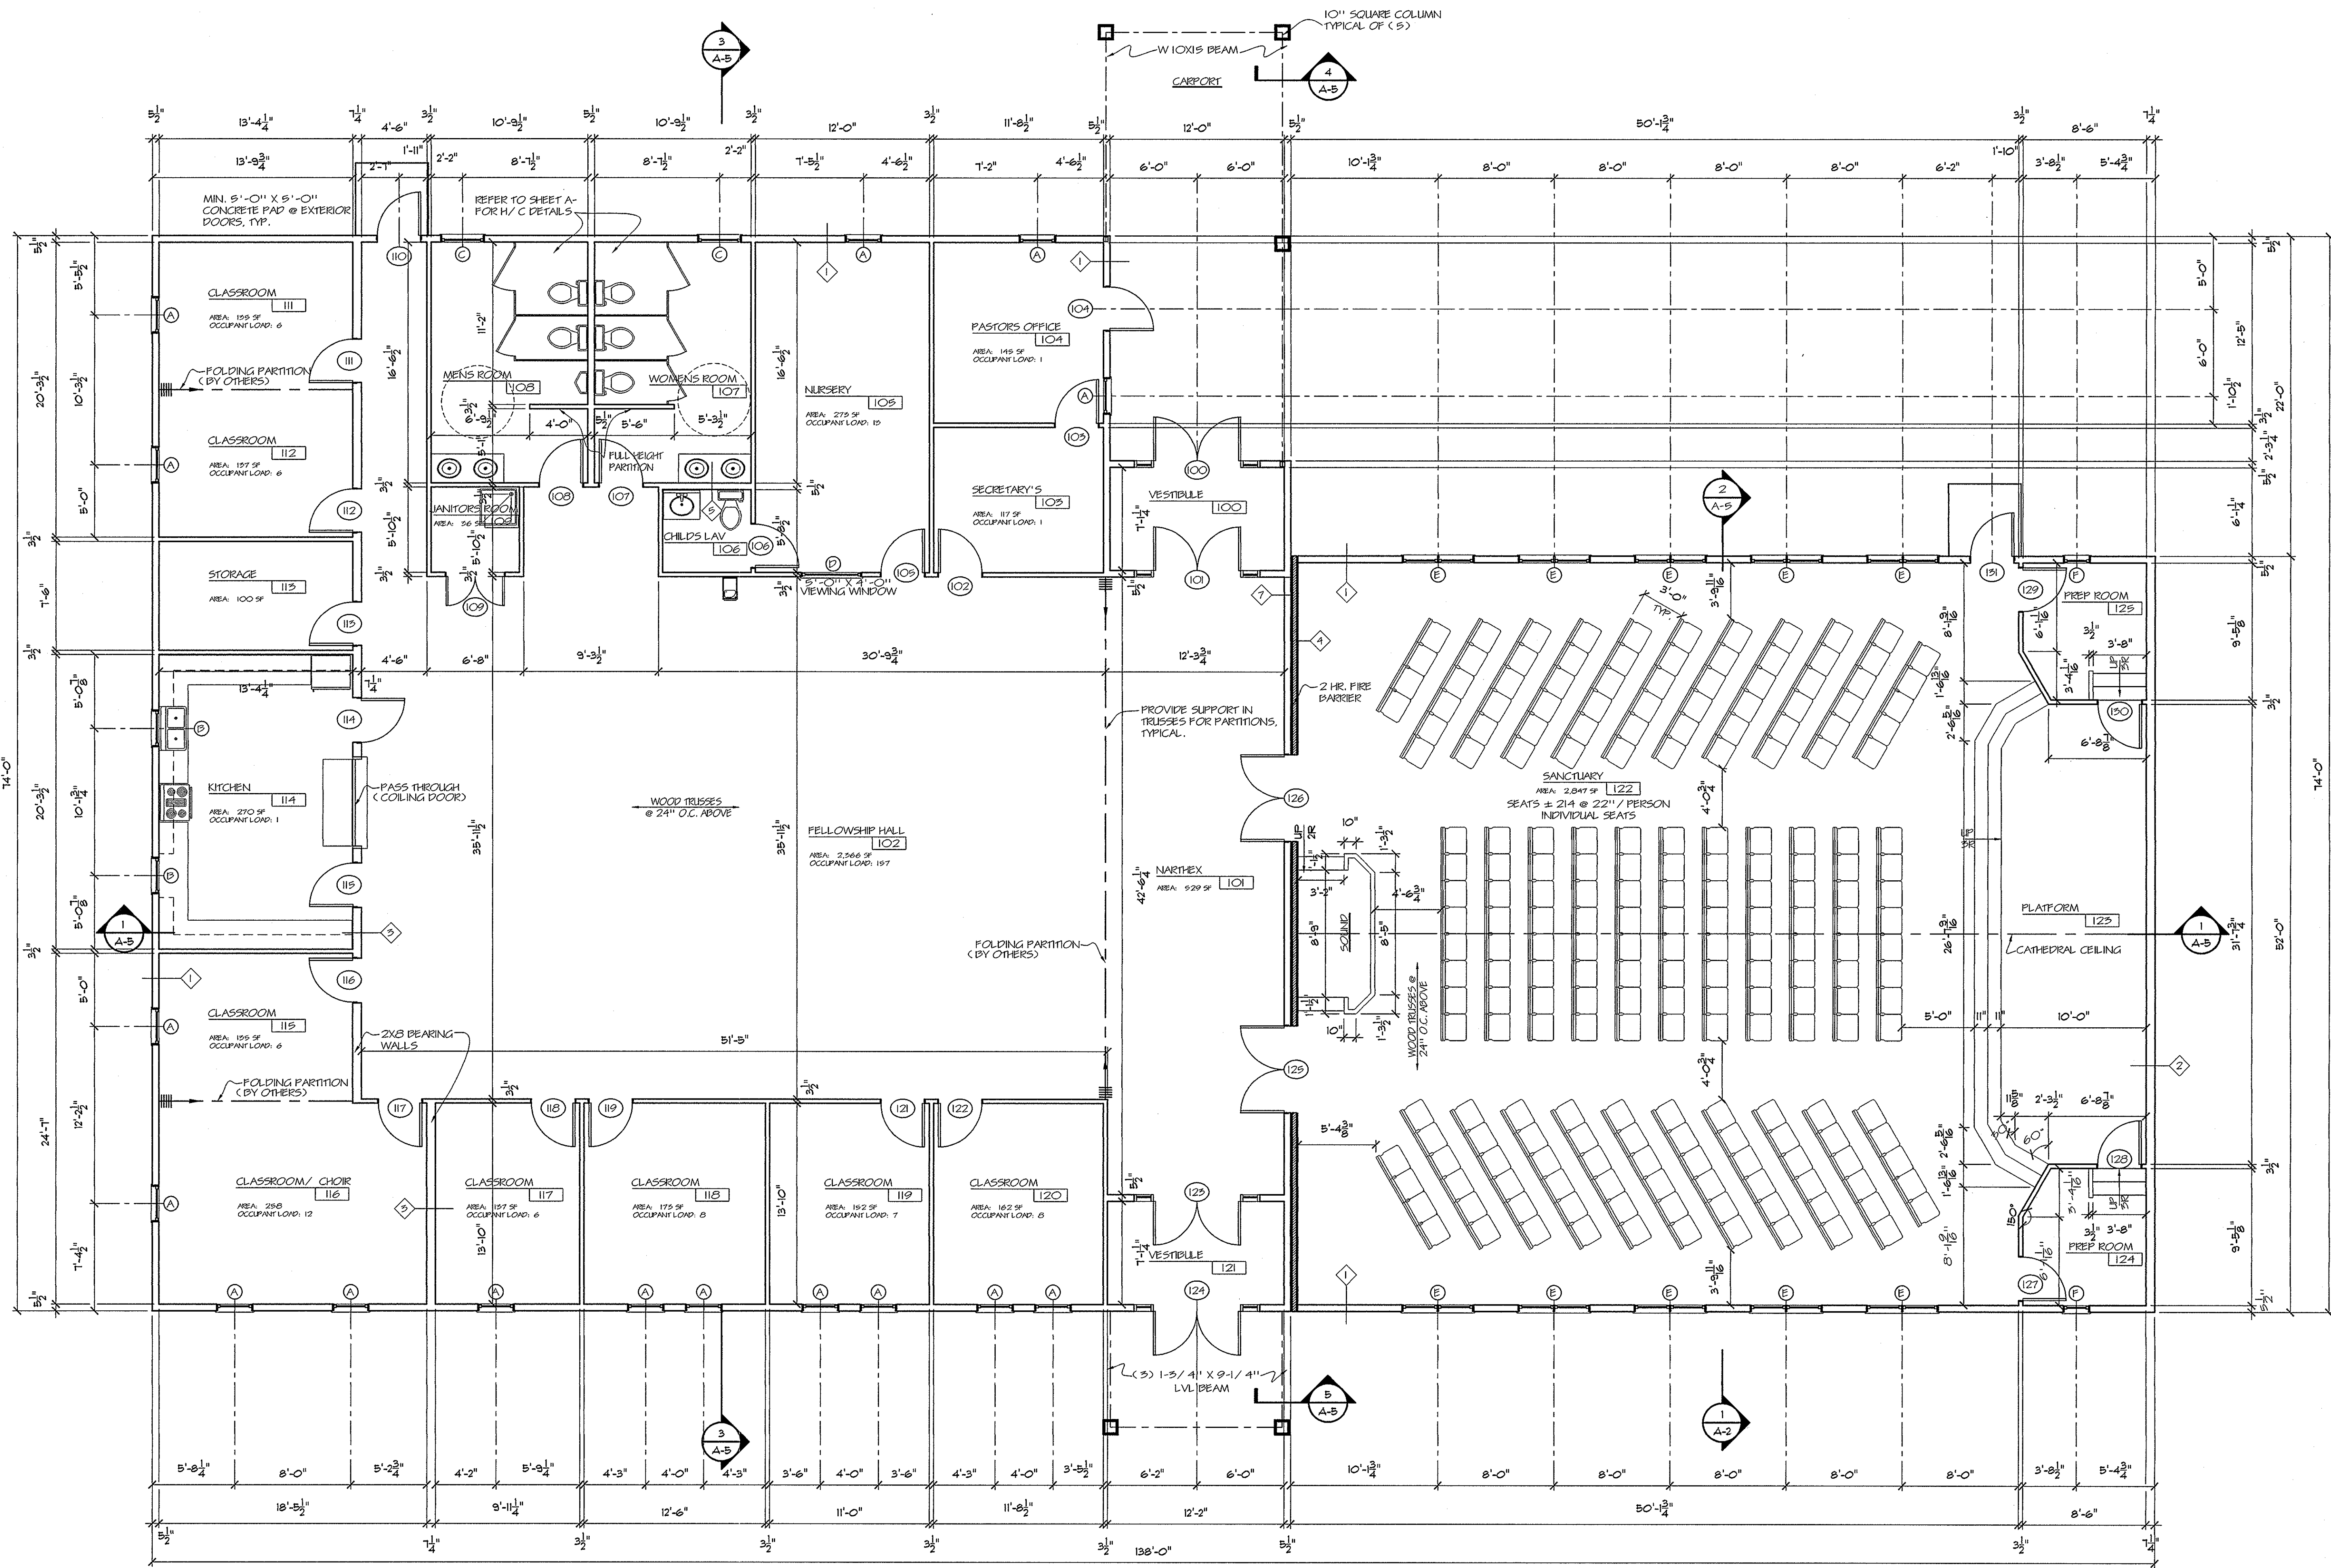

**FLOOR PLAN**  
SCALE: 3/16" = 1'-0"

J. R. Frandsen, P. E.  
P.O. Box 426 \* 3310 State Route 352  
Big Flats, New York 14814

REVISIONS NUMBER	DESCRIPTION	DATE	INITIALS
1	CHANGES PER BUILDING DEPT.	10/23/03	BAS

COPYRIGHT BARDEN & ROBERTSON CORP. 2002  
NOTICE: THIS SET OF PLANS AND THE DESIGN CONTAINED HEREIN IS THE PROPERTY OF BARDEN & ROBERTSON CORP. AND MAY NOT BE REPRODUCED FOR BUILDING UNLESS A WRITTEN CONTRACT HAS BEEN EXECUTED FOR THE PURCHASE OF MATERIALS TO COMPLETE THE DESIGN FROM BARDEN & ROBERTSON CORP. THIS PERSON SHALL NOT BE USED FOR ANY OTHER PURPOSE WITHOUT THE EXPRESS WRITTEN PERMISSION OF THE BARDEN & ROBERTSON CORP.

**IMPORTANT NOTICE**  
THESE DRAWINGS ARE PROVIDED BY BARDEN CHURCH BUILDING SERVICES AS A SERVICE TO THE CLIENT AND ARE NOT TO BE CONSIDERED COMPLETE FOR FINAL COSTING OR CONSTRUCTION UNTIL ALL FEDERAL, STATE, OR LOCAL APPROVALS ARE OBTAINED. THE RESPONSIBILITY OF SECURING THESE APPROVALS RESTS FULLY WITH THE CLIENT AND/OR THEIR CONTRACTOR.

OWNER/CONSTRUCTION MANAGER  
**REVIVAL DEVELOPMENT**  
ROB TULLY

DATE: 1/7/03	SCALE: AS SHOWN	DRAWN BY: BAS
--------------	-----------------	---------------

CLIENT/PROJECT TITLE: **FIRST UNITED METHODIST CHURCH OF WEST AUSTINTOWN**  
PROJECT LOCATION: **6749 MAHONING AVE. AUSTINTOWN, OH**  
SHEET: **FLOOR PLAN**

**barden**  
CHURCH BUILDING SERVICES  
P.O. Box 310 Middleport, New York 14105  
800-724-0141 \* fax 716-735-3752 \* 716-735-3752

PROJECT NO: **2023.01**

PROCESSING NO:  
DWG NO: **A-3**  
SHEET 4 OF 8